






FRONT ELEVATION
SCALE 1/4"=1'-0"

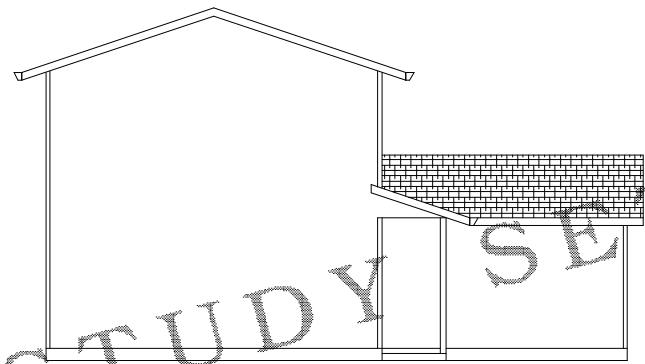

LEFT SIDE ELEVATION
SCALE 1/8"=1'-0"

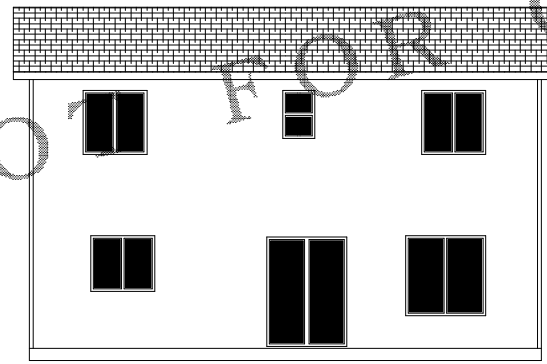


REAR ELEVATION
SCALE 1/8"=1'-0"

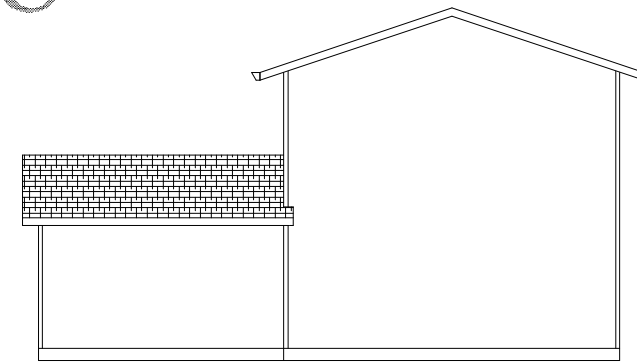

RIGHT SIDE ELEVATION
SCALE 1/8"=1'-0"

STUDY SET NOT FOR CONSTRUCTION

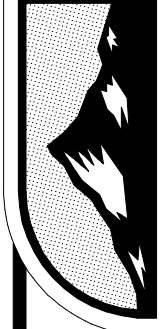


STUDY SET

DESIGN NORTHWEST INC. • 14602-D NE 4TH PLAIN VANCOUVER WA 98682 • PH: (360) 260-1766

ALL RIGHTS RESERVED. THIS SET OF PLANS IS THE PROPERTY OF DESIGN NORTHWEST INC. AND IS TO BE USED ONLY FOR THE PROJECT AND SITE SPECIFICALLY IDENTIFIED HEREIN. ANY REUSE OR MODIFICATION OF THESE PLANS WITHOUT THE WRITTEN PERMISSION OF DESIGN NORTHWEST INC. IS STRICTLY PROHIBITED.

REV		
REV	6/5/07	JF
REV	10/12/14	RWD

PLAN 1228

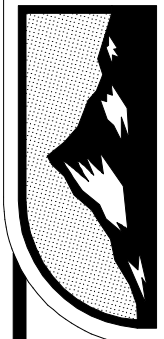


STUDY SET

DESIGN NORTHWEST INC. • 14602-D NE 4TH PLAIN VANCOUVER WA 98682 • PH: (360) 260-1766

ALL RIGHTS RESERVED FOR THIS SET OF PLANS. NO PART OF THESE PLANS MAY BE REPRODUCED OR TRANSMITTED IN ANY FORM OR BY ANY MEANS, ELECTRONIC OR MECHANICAL, INCLUDING PHOTOCOPYING, RECORDING, OR BY ANY INFORMATION STORAGE AND RETRIEVAL SYSTEM, WITHOUT THE WRITTEN PERMISSION OF DESIGN NORTHWEST INC. ANY REVISIONS TO THESE PLANS SHALL BE MADE IN ACCORDANCE WITH THE REVISIONS SHEET ATTACHED TO THESE PLANS.

PLAN 1228

2

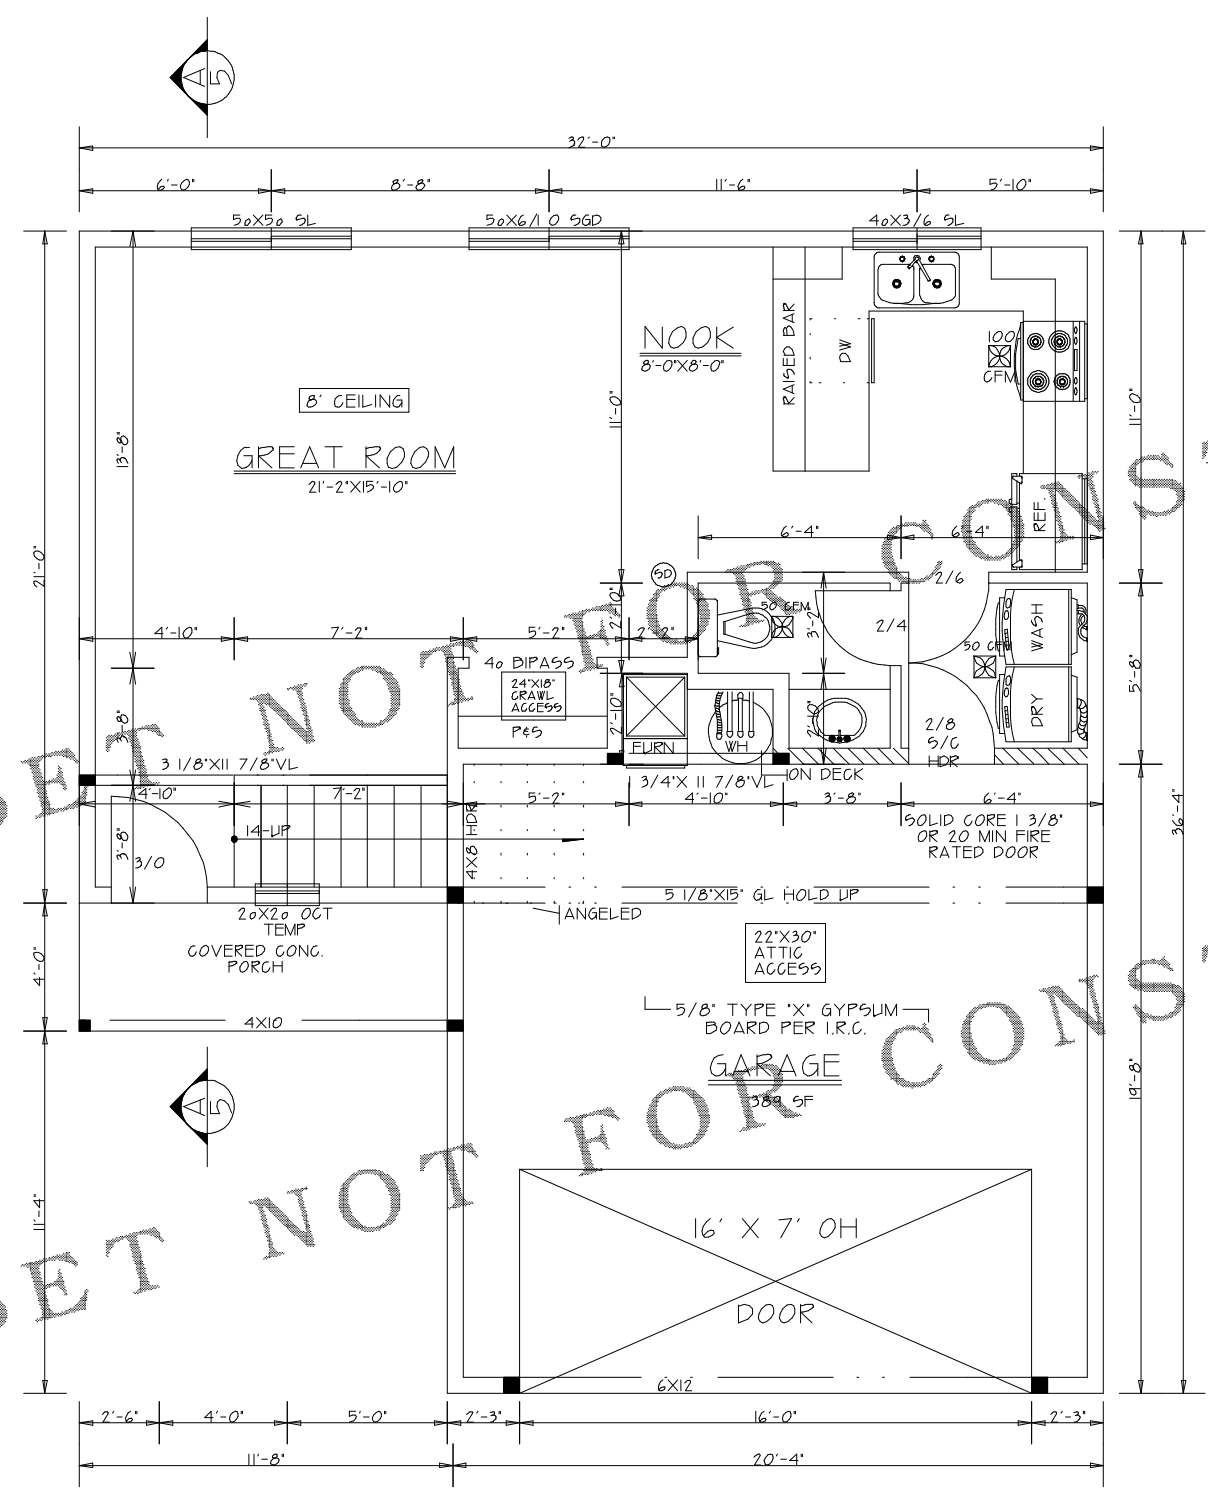

NOTE: ■ BLACKENED AREA = POINT LOADS OR POSTS

4X10 HDR MIN. 8'-0" CEILINGS
4X10 HDR MIN. 9'-0" CEILINGS
UNLESS NOTED ON PLAN

SIMPSON 'EPD444' POST BASE AND
SIMPSON 'BC4' POST CAP OR EQU.
FOR 4X4 POST CONNECTIONS


SIMPSON 'CB66' POST BASE AND
SIMPSON 'BC6' POST CAP OR EQU.
FOR 6X6 POST CONNECTIONS

SMOKE DETECTORS SHALL BE INSTALLED IN EACH SLEEPING ROOM AND CENTRALLY LOCATED IN ADJACENT CORRIDOR. SMOKE DETECTORS SHALL BE INSTALLED ON EACH FLOOR LEVEL AND IN BASEMENTS. DETECTORS SHALL SOUND ALARM AUDIBLE IN ALL SLEEPING AREAS AND SHALL BE EQUIPPED WITH BATTERY BACK-UP.

FLOOR PLAN
SCALE 1/4"=1'-0"

AREA	
1ST FLOOR	585 SF
2ND FLOOR	633 SF
TOTAL	1218 SF

STUDY SET NOT FOR CONSTRUCTION

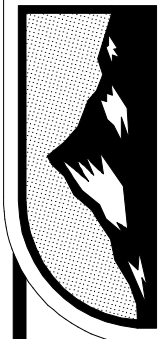


STUDY SET

DESIGN NORTHWEST INC. • 14602-D NE 4TH PLAIN VANCOUVER WA 98682 • PH: (360) 260-1766

REV	10/12/14	RWD
REV	6/5/07	JF
REV		
REV		

PLAN 1228

3

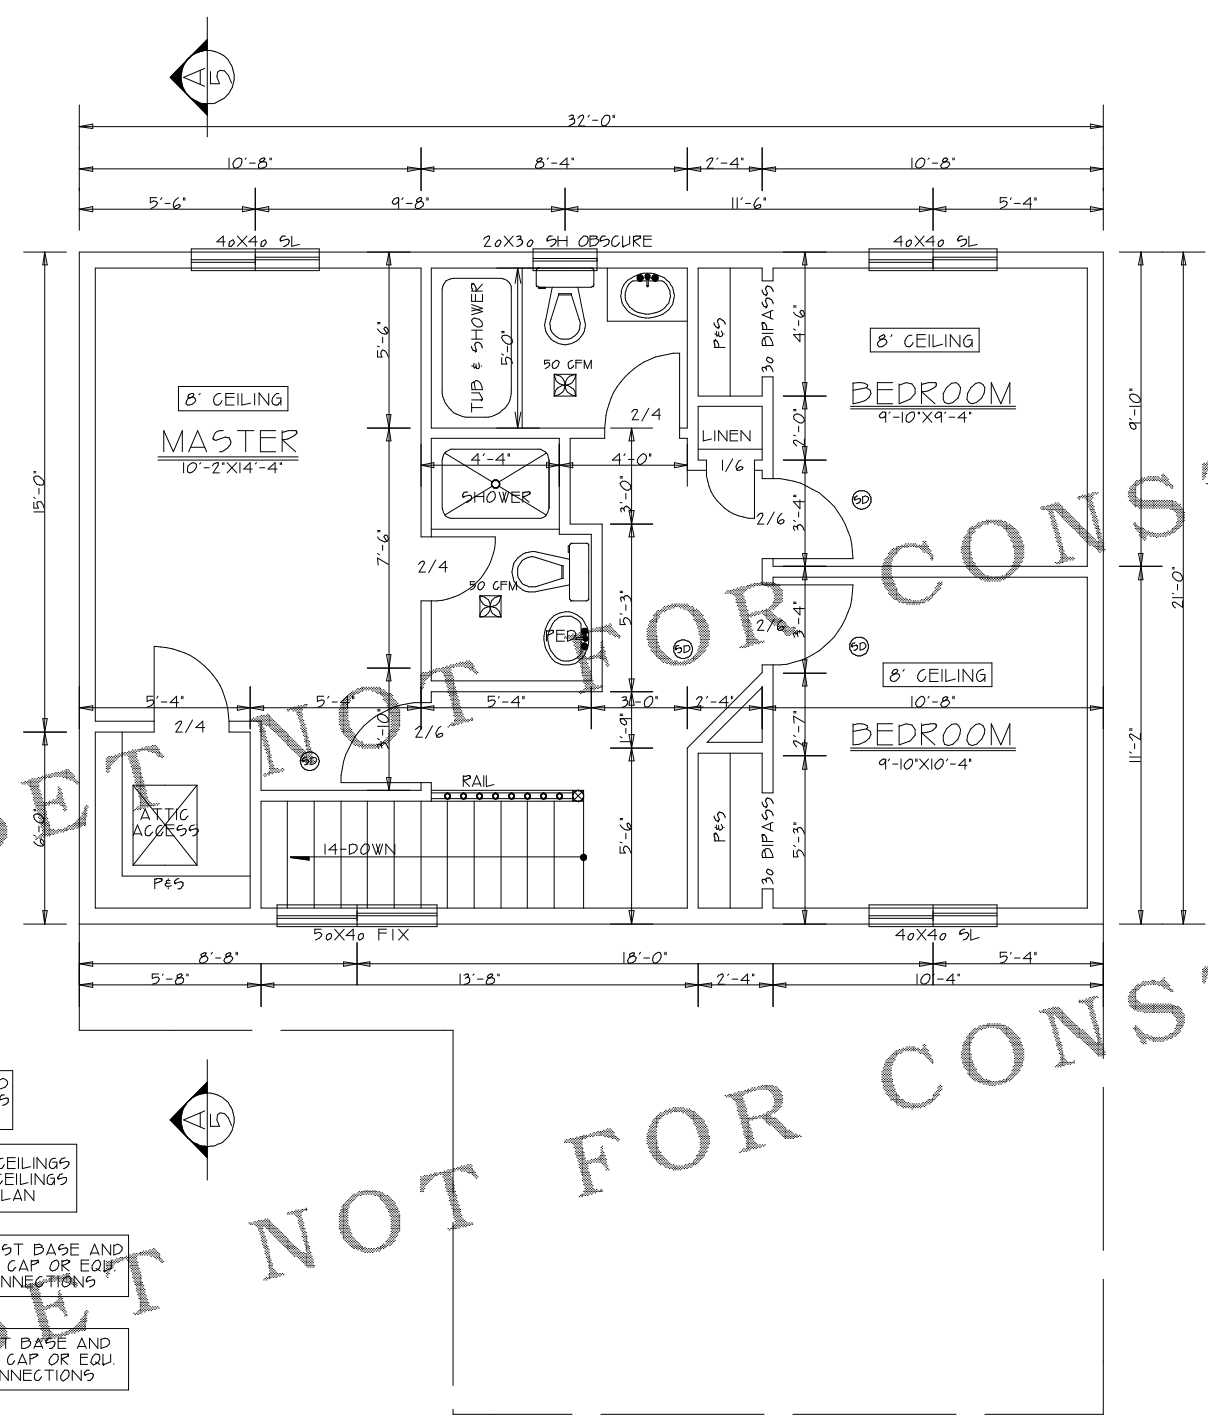

- NOTE: ■ BLACKENED AREA - POINT LOADS OR POSTS
- 4X10 HDR MIN. 8'-0" CEILING
4X10 HDR MIN. 9'-0" CEILING
UNLESS NOTED ON PLAN
- SIMPSON 'EPB44T' POST BASE AND SIMPSON 'BC4' POST CAP OR EQU. FOR 4X4 POST CONNECTIONS
- SIMPSON 'CB66' POST BASE AND SIMPSON 'BC6' POST CAP OR EQU. FOR 6X6 POST CONNECTIONS
- SMOKE DETECTORS SHALL BE INSTALLED IN EACH SLEEPING ROOM AND CENTRALLY LOCATED IN ADJACENT CORRIDOR. SMOKE DETECTORS SHALL BE INSTALLED ON EACH FLOOR LEVEL AND IN BASEMENTS. DETECTORS SHALL SOUND ALARM AUDIBLE IN ALL SLEEPING AREAS AND SHALL BE EQUIPPED WITH BATTERY BACK-UP.

2ND FLOOR PLAN
SCALE 1/4"=1'-0"

STUDY SET NOT FOR CONSTRUCTION