



STUDY SET NOT FOR CONSTRUCTION

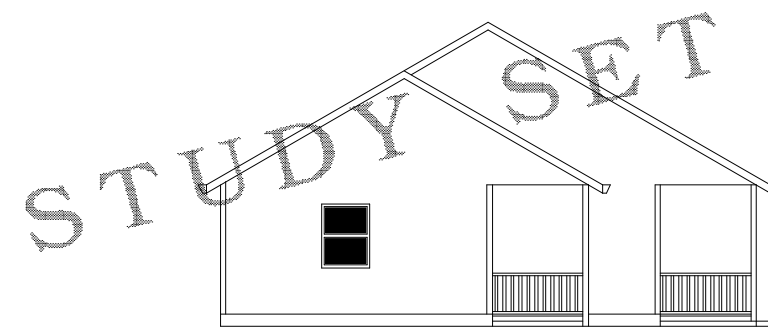


FRONT ELEVATION
SCALE 1/4"=1'0"




LEFT SIDE ELEVATION
SCALE 1/8"=1'0"

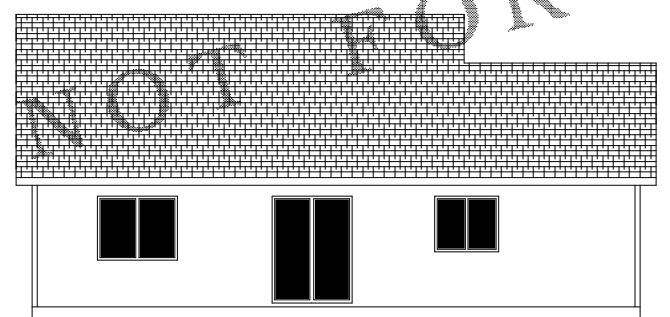

REAR ELEVATION
SCALE 1/8"=1'0"

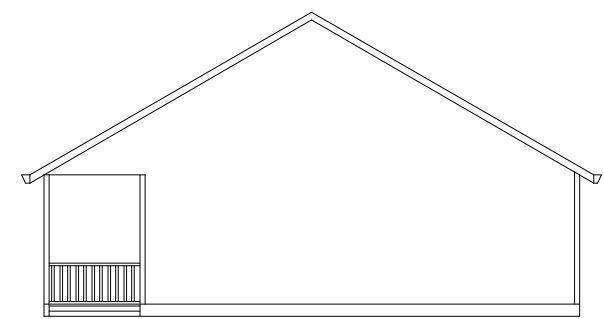

RIGHT SIDE ELEVATION
SCALE 1/8"=1'0"

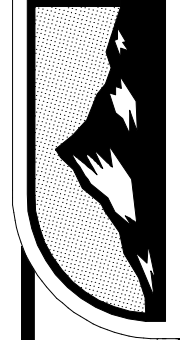


STUDY SET

DESIGN NORTHWEST INC. • 14602-D NE 4TH PLAIN VANCOUVER WA 98082 • PH: (360) 280-1766 • www.DesignNW.net

ALL CONSTRUCTION TO BE IN ACCORDANCE WITH THE 2006 INTERNATIONAL RESIDENTIAL CODE BOOK (IRC) AND THE 2006 INTERNATIONAL ENERGY EFFICIENCY CODE (IEEC). THE CLIENT IS RESPONSIBLE FOR OBTAINING ALL NECESSARY PERMITS AND APPROVALS FROM THE LOCAL BUILDING DEPARTMENT. THE ARCHITECT ASSUMES NO LIABILITY FOR CONSTRUCTION DEFECTS OR INADEQUACIES OF MATERIALS OR WORKMANSHIP. THE ARCHITECT'S RESPONSIBILITY IS LIMITED TO THE DESIGN AND CONSTRUCTION OF THE PROJECT AS SHOWN ON THESE PLANS.

ORIG	10/22/03	RD
REV	9/19/07	LF
REV		
REV		


PLAN 917

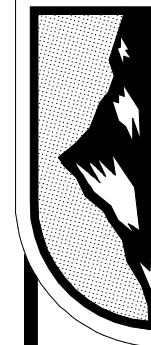

STUDY SET

DESIGN NORTHWEST INC. • 14802-D NE 4TH PLAIN VANCOUVER WA 98082 • PH: (360) 280-1766 • www.DesignNW.net

STUDY SET NOT FOR CONSTRUCTION

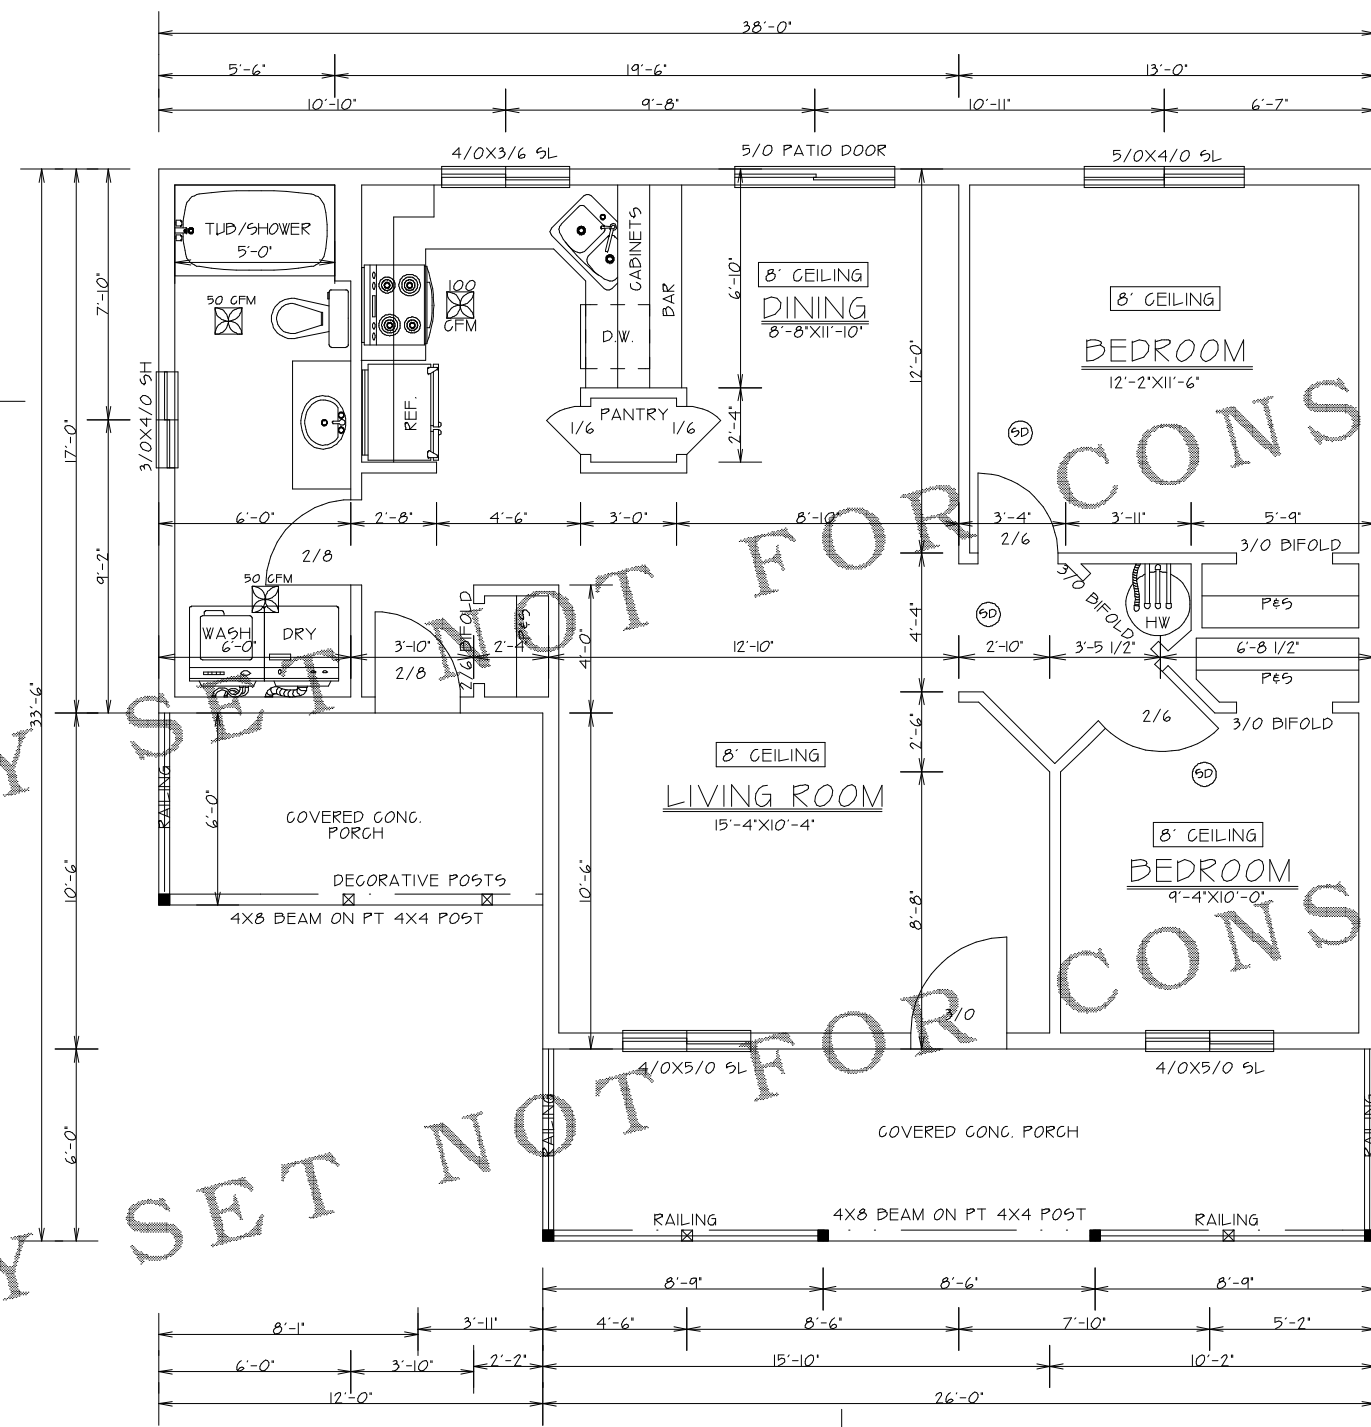

4X10 HDR MIN. 8'-0" CEILINGS
4X10 HDR MIN. 9'-0" CEILINGS

SIMPSON 'EPB44T' POST BASE AND
SIMPSON 'BC4' POST CAP OR EQU.
FOR 4X4 POST CONNECTIONS

SIMPSON 'GB66' POST BASE AND
SIMPSON 'BC6' POST CAP OR EQU.
FOR 6X6 POST CONNECTIONS

SMOKE DETECTORS SHALL BE INSTALLED IN
EACH SLEEPING ROOM AND CENTRALLY LOCATED
IN ADJACENT CORRIDOR. SMOKE DETECTORS
SHALL BE INSTALLED ON EACH FLOOR LEVEL
AND IN BASEMENTS. DETECTORS SHALL SOUND
ALARM AUDIBLE IN ALL SLEEPING AREAS AND
SHALL BE EQUIPPED WITH BATTERY BACK-UP.

FLOOR PLAN
SCALE 1/4"=1'-0"

AREA
917 SF

PLAN	917
	2